


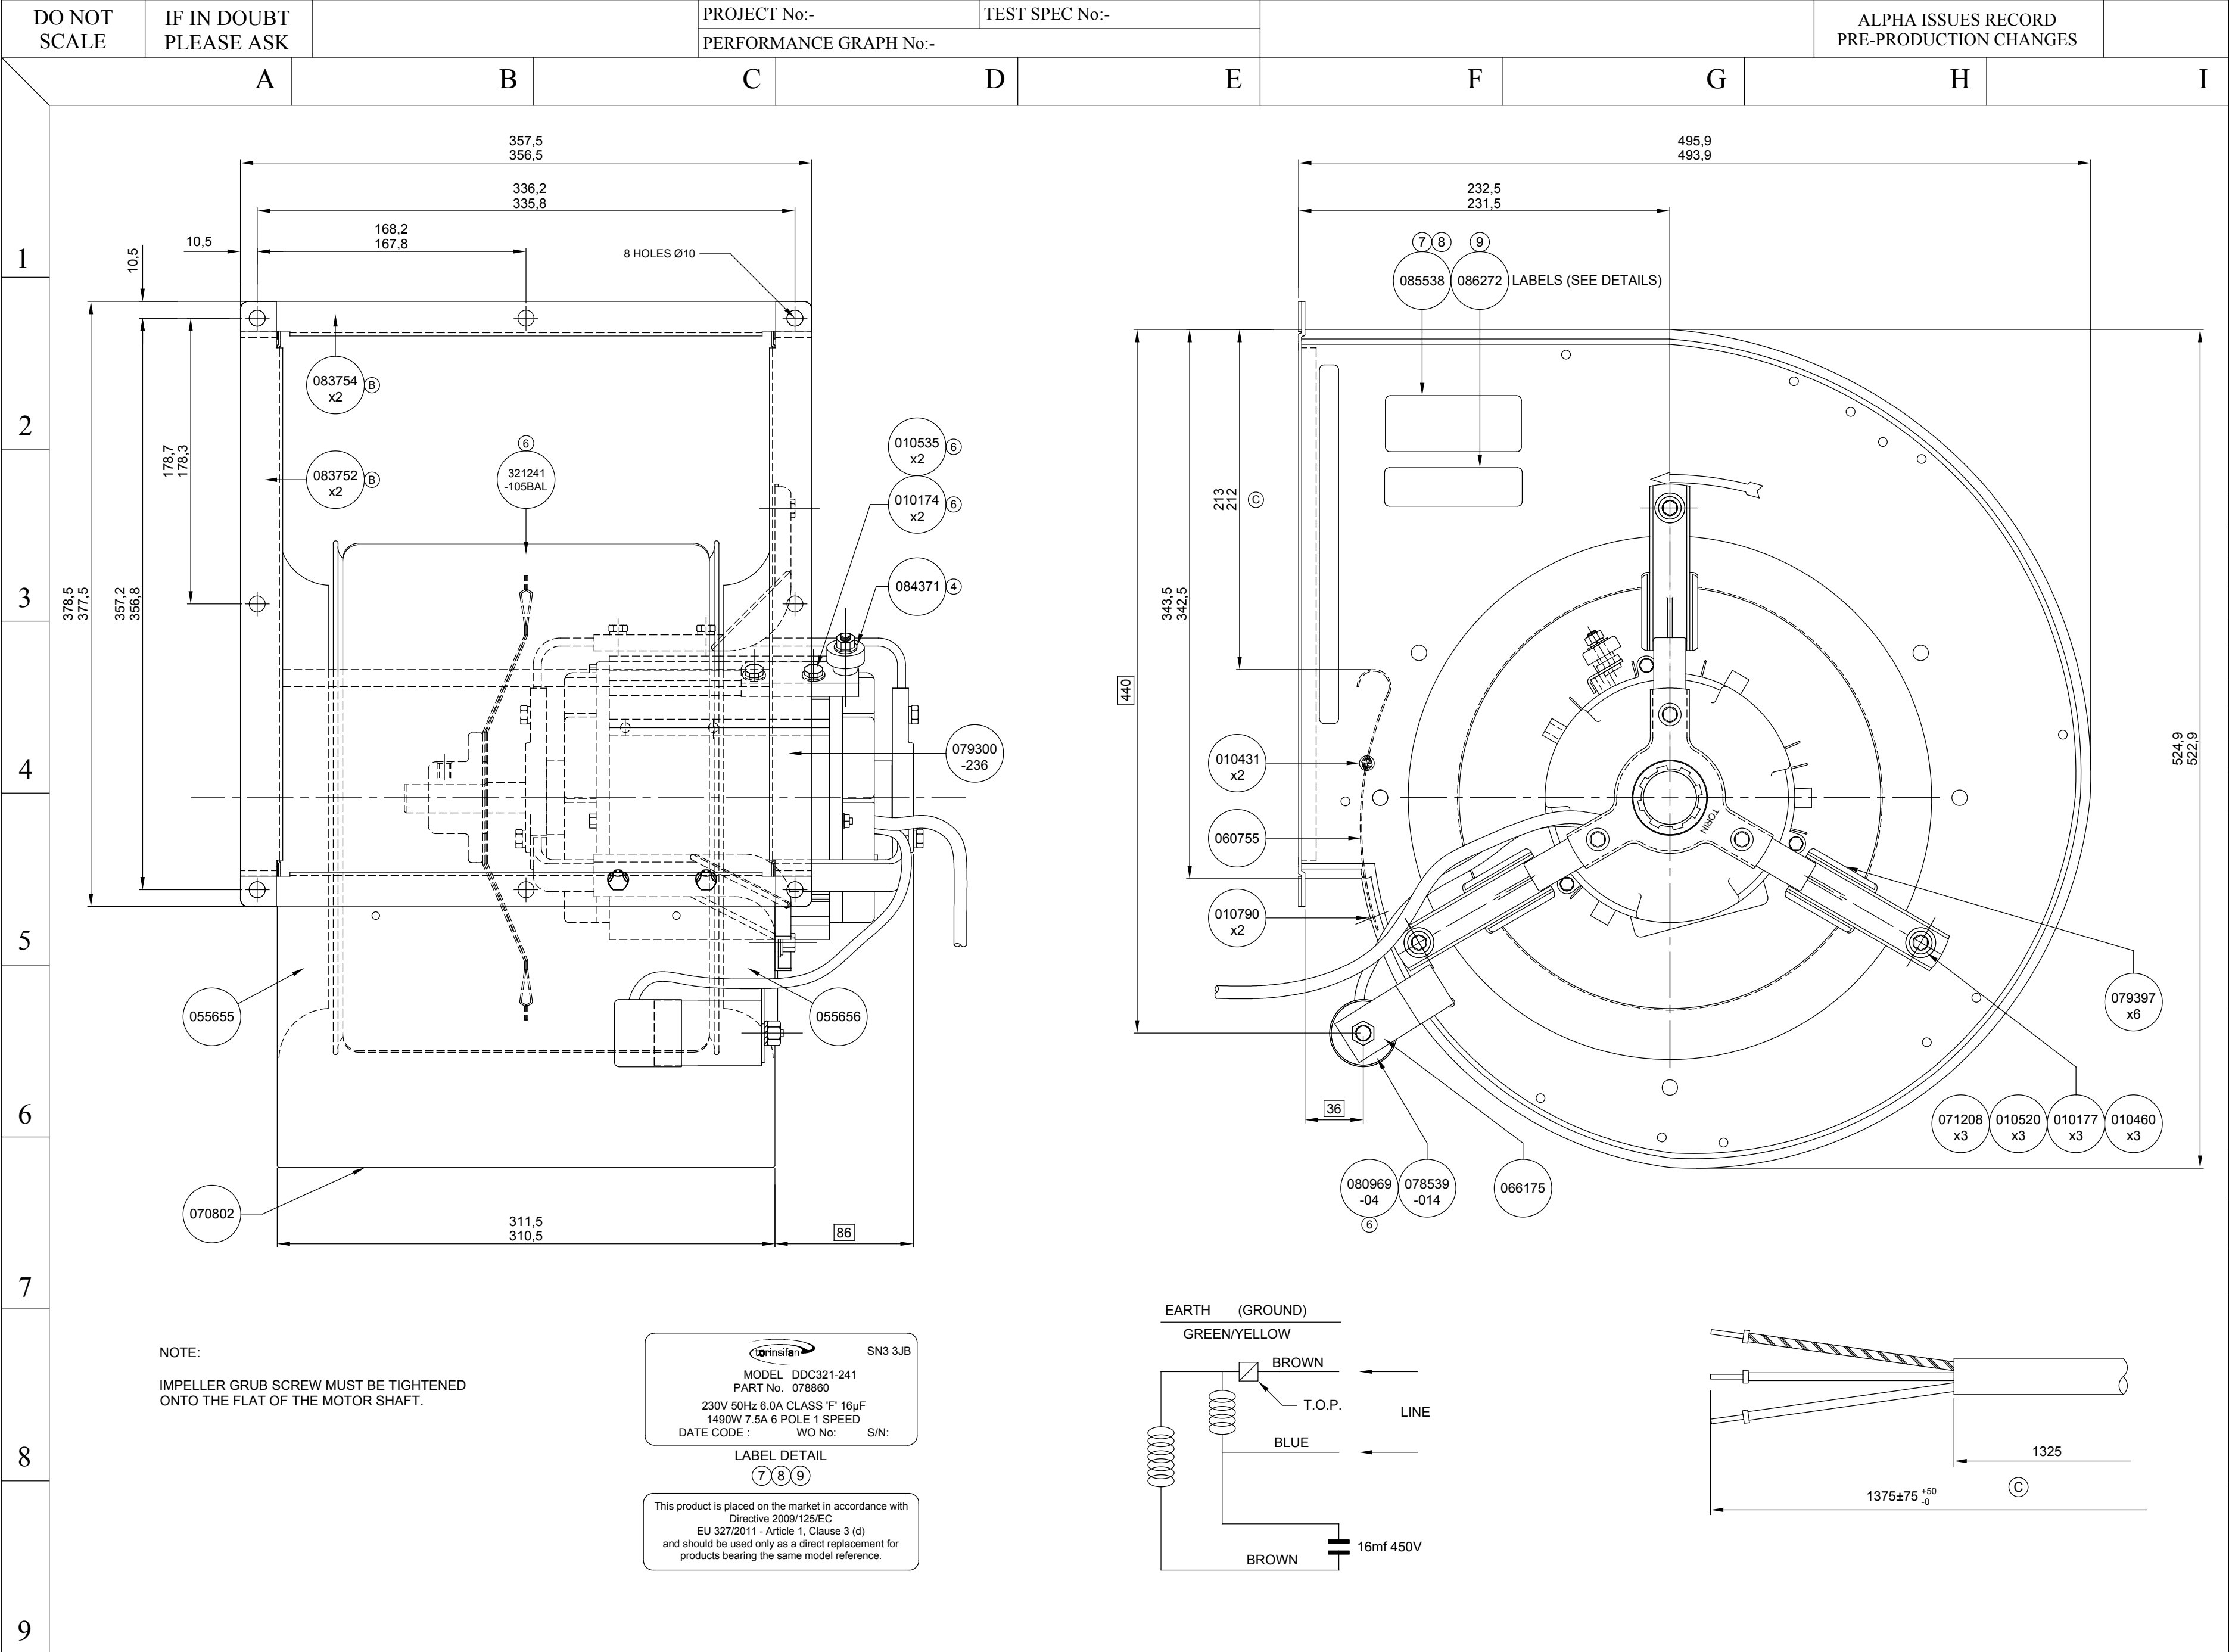

9	ADD ERP SPARE LABEL 086272	22/12/20	20623
8	LABEL 085538 WAS 084818	23/11/09	17966C
7	NEW LABEL DETAILS	10/11/06	17062
6	IMPELLER CHANGED FROM 321241-105FBAL TO 321241-105BAL	22/09/06	17017
5		23/06/06	16975
4	MOTOR CHANGED	04/12/03	16312
C		07/06/02	16014
B	OUTLET FLANGES CHANGED	17/11/99	15423
A		16/05/94	13690
ISS.	MODIFICATION	DATE	C/N NO.
MATERIAL			
GALV			
FINISH			
NATURAL			
FIRST USED ON			
SIMILAR TO 078860-00			
DIRECTORY PATH ASY/DDC/321-241/WF/078860			
TITLE			
DDC321-241 230V 50Hz 750W 6 POLE 1 SPEED			
DRAWING NO.			
078860			
098870			
DRAWING NO.			